

LUMINAIRE SCHEDULE

CALLOUT	SYMBOL	LAMP	DESCRIPTION	BALLAST	MOUNTING	MODEL	VOLTS	QUANTITY	VOLTS	DEFAULT ELEVATION	LUMENS / LAMP	TOTAL LUMENS	LAMP DEPRECIATION
A	□	(1) 60 TYPE XP-G2 LEDs	228 Series Recessed Canopy Upgrade, Type V Medium, 60 LEDs, 700mA, 4000K	ELECTRONIC	CEILING	Cree Inc. CAN-228-5M-RTx-06-E-UL-700-40K OR BXCTBx506-UDx7	120V 1P 2W	8	120	15'-0"	0	1	1
B	○	(1) LED, NICHIA 219B	CONTOUR SERIES LED WALL-MOUNT WITH 30 4000K LEDS OPERATED AT 700mA AND PRECISION MOLDED ACRYLIC TYPE II LENS	ELECTRONIC	WALL	Lithonia Lighting, CSXW LED 30C 700 40K T2M	120V 1P 2W	3	120	8'-0"		0	1
C	○-□	UNKNOWN LED	EXISTING STREET LIGHT	ELECTRONIC	ARM	UNKNOWN	UNKNOWN	UNKNOWN	UNKNOWN	UNKNOWN	UNKNOWN	UNKNOWN	UNKNOWN

Registration



Design Team

KDA
 Design BK
 Drawn BK
 Client Project No. -
 KDA Project No. GSA-01

Owner

-

Project

Mercer Island Shell Addition/Alteration

Issue/Revision

No.	Date	Description
1	3-12-20	SCHEMATIC
2	5-11-20	SCHEMATIC REV
3	2-25-21	DESIGN REVIEW
R1	06/10/21	HEALTH PERMIT REVISIONS
4	8-5-21	SITE DEVELOP PERMIT

Sheet Title

SITE LIGHTING PLAN


Print Date

3/12/2020

Copyright 2020 KAUL DESIGN ARCHITECTURE, PLLC

Sheet No.

E1.0

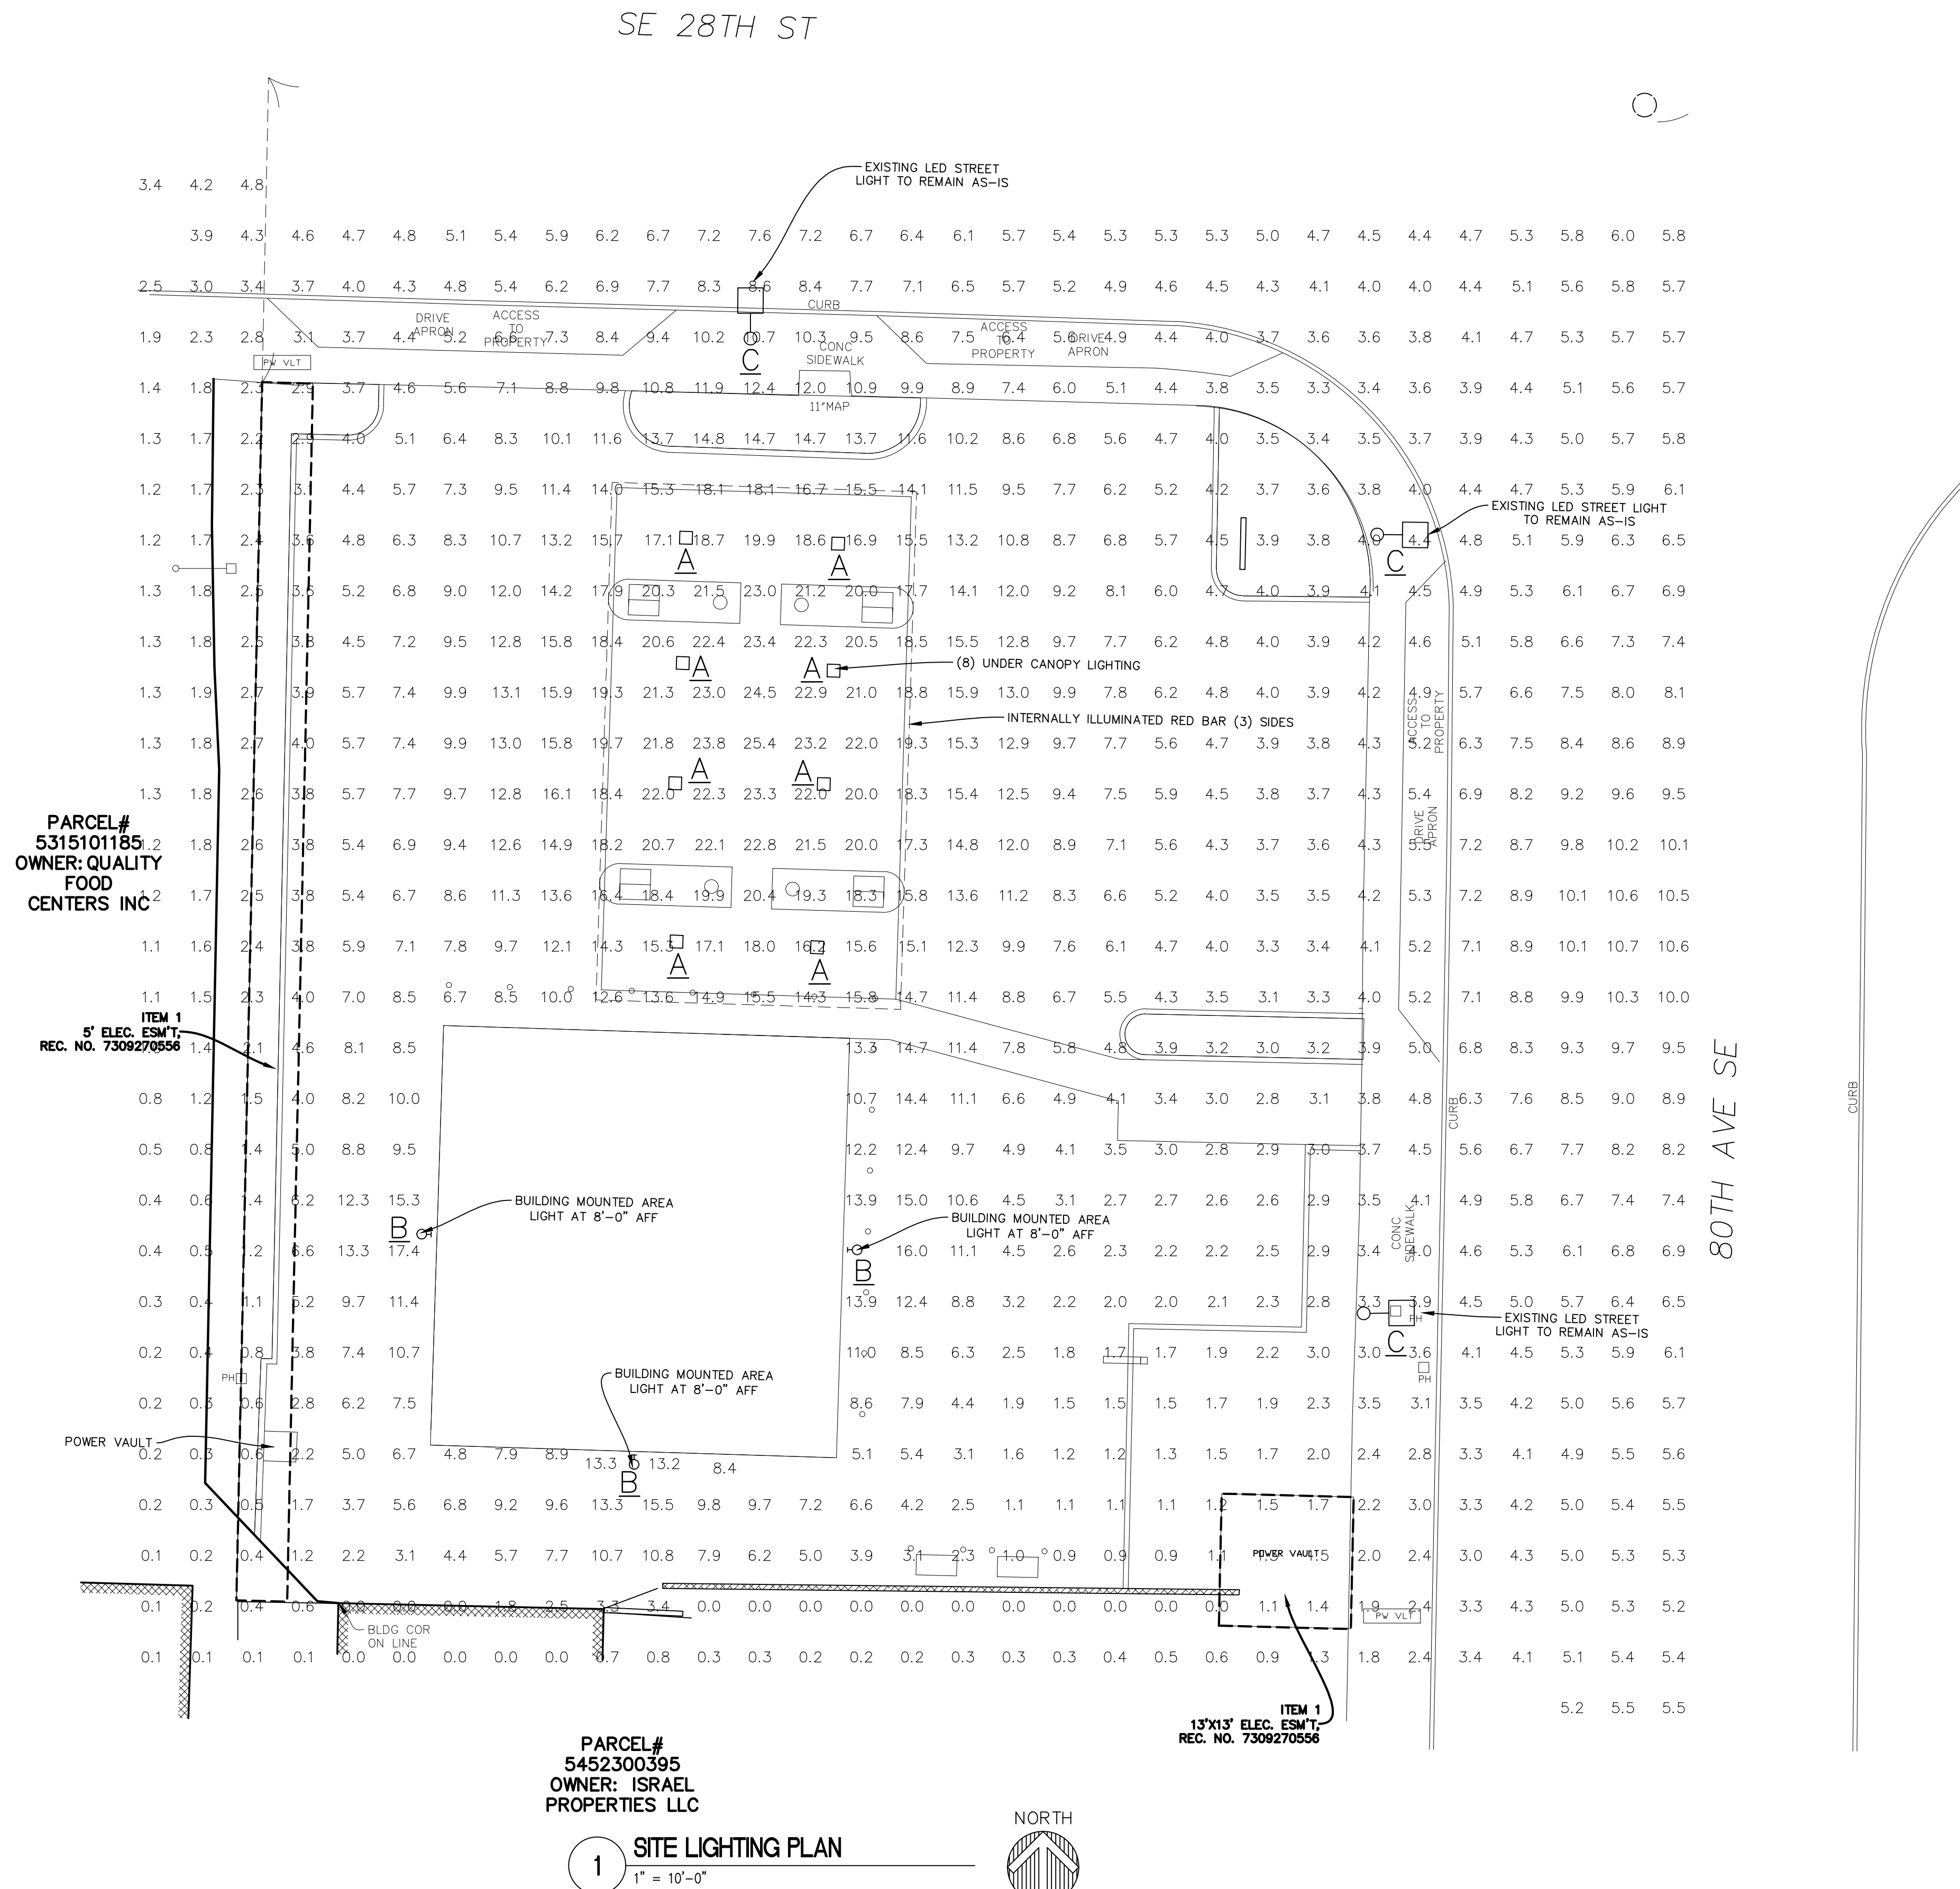

PARCEL# 5452300395
OWNER: ISRAEL PROPERTIES LLC

1 SITE LIGHTING PLAN
1" = 10'-0"

NORTH

