



Vicinity Map (NTS)

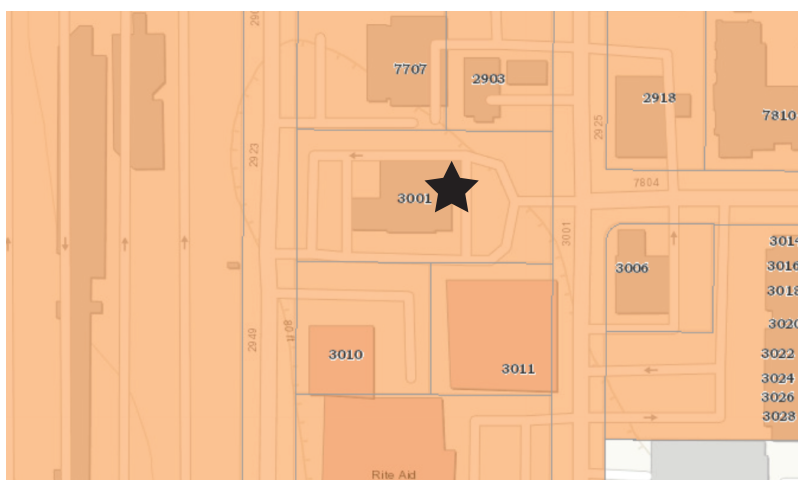

Zoning Map (NTS)


WELLS FARGO

3001 78TH AVE SE
 MERCER ISLAND, WA 98040
 Parcel: 5315101085
 Zone: TC (TOWN CENTER)

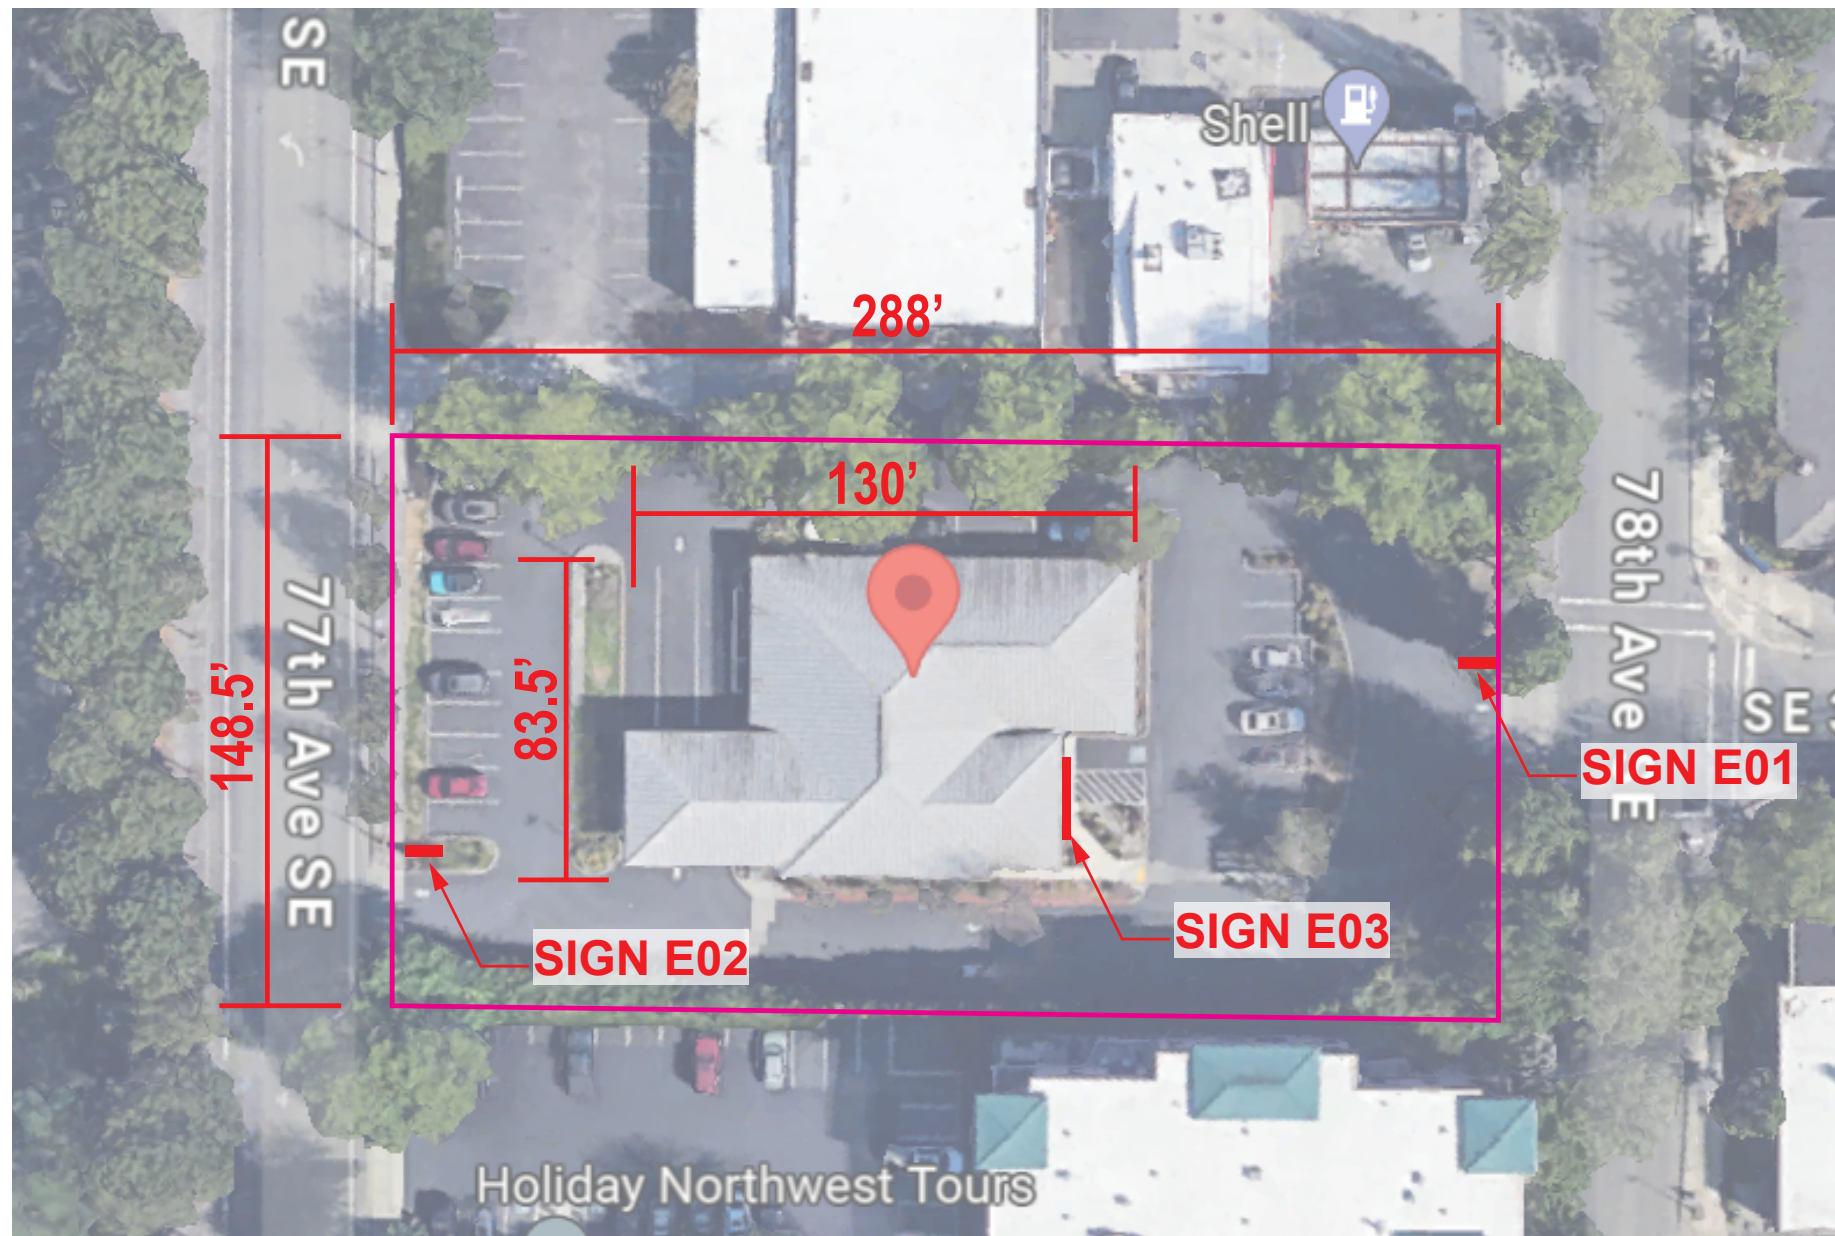

Site Plan (Scale 1"=50'-0")



 City Lights Sign Company 902 NW 49th St Seattle WA 98107 Ph: 206 -789-4747 Cell: 206-255-7029	Client:	Date:	This drawing was created to assist you. The drawing and ideas are the property of City Lights Sign Co. and cannot be replicated or used without the written permission of City Lights Sign Co. Ask your City Lights Sign Co rep for written permission.	
	WELLS FARGO	03.26.24		
	Address:	City:		Job Number:
	3001 78TH AVE SE	MERCER ISLAND 98040		