




**MONUMENT SIGN
NO LONGER
PART OF SCOPE.**

**RETROFIT EXISTING
SIGNS ONLY**

Colors and materials

-  White
-  Red
-  Yellow

-  Red
-  Yellow
-  White

- 1. [Illegible text]
- 2. [Illegible text]
- 3. [Illegible text]
- 4. [Illegible text]
- 5. [Illegible text]
- 6. [Illegible text]
- 7. [Illegible text]
- 8. [Illegible text]
- 9. [Illegible text]
- 10. [Illegible text]
- 11. [Illegible text]
- 12. [Illegible text]
- 13. [Illegible text]
- 14. [Illegible text]
- 15. [Illegible text]
- 16. [Illegible text]
- 17. [Illegible text]
- 18. [Illegible text]
- 19. [Illegible text]
- 20. [Illegible text]
- 21. [Illegible text]
- 22. [Illegible text]
- 23. [Illegible text]
- 24. [Illegible text]
- 25. [Illegible text]
- 26. [Illegible text]
- 27. [Illegible text]
- 28. [Illegible text]
- 29. [Illegible text]
- 30. [Illegible text]
- 31. [Illegible text]
- 32. [Illegible text]
- 33. [Illegible text]
- 34. [Illegible text]
- 35. [Illegible text]
- 36. [Illegible text]
- 37. [Illegible text]
- 38. [Illegible text]
- 39. [Illegible text]
- 40. [Illegible text]
- 41. [Illegible text]
- 42. [Illegible text]
- 43. [Illegible text]
- 44. [Illegible text]
- 45. [Illegible text]
- 46. [Illegible text]
- 47. [Illegible text]
- 48. [Illegible text]
- 49. [Illegible text]
- 50. [Illegible text]



PHILADELPHIASIGN
BRINGING THE WORLD'S BRANDS TO LIFE

707 West Spring Garden Street
Palmyra, New Jersey 08065

Phone: 856.829.1460
Fax: 856.829.8549
www.philadelphiasign.com

CUSTOMER:
WELLS FARGO

JOB NUMBER:

SIGN TYPE:
**WFR2-M-22
PSCO WF_R2_MON_M22**

LOCATION:

DATE:
4/3/24


DRAWN BY:
KJH

REVISION:
Number: Date: By:

SHEET: **ENG DEPT**
1 OF 1

DWG NUMBER:
B-108740

ENGINEER SEAL:

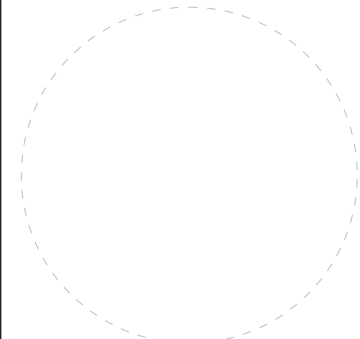

ULTIMATE WIND SPEED 115 MPH
EXPOSURE C

THIS IS AN ORIGINAL UNPUBLISHED DRAWING
CREATED BY PSCO. IT IS SUBMITTED FOR YOUR
PERSONAL USE IN CONJUNCTION WITH A PROJECT
BEING PLANNED FOR YOU BY PSCO. IT IS NOT TO
BE SHOWN TO ANYONE OUTSIDE YOUR
ORGANIZATION NOR IS IT TO BE USED, COPIED,
REPRODUCED, OR EXHIBITED IN ANY FASHION.

Client:	WELLS FARGO	Date:	03.26.24
Address:	3001 78TH AVE SE	Job Number:	
City:	MERCER ISLAND		
State:	WA 98040		
City Lights Sign Company	902 NW 49th St Seattle WA 98107 Ph: 206-789-4747 Cell: 206-255-7029		

WELLS FARGO MONUMENT SIGN

NO LONGER

PART OF SCOPE.

RETROFIT EXISTING

SIGNS ONLY

Flex Face to be 3M Panagraphics III w/
3M #3630-2538 Wells Fargo Environments
Red Vinyl Applied First Surface. Graphics
Dropped Out to Expose White Surface.

Fabricated Aluminum Tubular Sign Case Frame
w/ Sign Comp Flat Bleed Retro Frame II, #2107
Painted AKZO Reflective White (Satin Finish) w/
3M #3630-2538 Wells Fargo Environments Yellow
Translucent Vinyl, Applied First Surface

Environments Yellow Translucent Vinyl,
Applied First Surface

120 Volt Flush Mount Photocell

3/4" Dia PVC Conduit for Primary Power

(6) #3 R-Bar Stirrups 16" OD
w/ 6" Overlap, (3) within Top 6" and
7-1/2" OC to Bottom. Anchor Bolts to
be 1/2" Dia x 6" Lg.

3/4" Dia
Anchor Bolts
(5)

24" Dia x 36" Deep Concrete Footing

SIDE ELEVATION
SCALE: 3/4" = 1' 0"


BASE PLATE DETAIL
SCALE: 1-1/2" = 1'-0"

- STANDARD MONUMENT NOTES:**
- Sufficient Primary Circuit In Vicinity Of Sign By Others.
 - Final Primary Hook-up By Sign Installer, Where Allowed By Local Codes.
 - Sign Shall Be U.L. Listed.
 - Soil Assumed To Be 250 psf/ft Lateral Bearing Pressure (psf/ft below natural grade).
 - Concrete 3,000 PSI @ 28 Days.
 - Reinforcing Steel Shall Be ASTM A615 GR-40.
 - Structural Steel Shall Be ASTM A36.
 - All Welds Shall Conform To A.W.S Standards.

Electrical Load
1.20 Amps @ 120 Volts
Electrical Req'mts
(1) 20 Amp/120 Volt Circuits

Note: This sign is intended to be installed in accordance with the requirements of Article 600 of the NFPA 2020 National Electrical Code and/or other Applicable local codes. This includes proper grounding and bonding of the sign.



 City Lights Sign Company 902 NW 49th St Seattle WA 98107 Ph: 206-789-4747 Cell: 206-255-7029	Client:	WELLS FARGO	Date:	03.26.24	This drawing was created to assist you. The drawing and ideas are the property of City Lights Sign Co. and cannot be replicated or used without the written permission of City Lights Sign Co. Ask your City Lights Sign Co rep for written permission.
	Address:	3001 78TH AVE SE	City:	MERCER ISLAND 98040	
Job Number:					



EXISTING

NOTE: NO CHANGE TO EXISTING LANDSCAPING

CUSTOM COMMENTS:
NOTE: FIELD VERIFICATION REQUIRED BEFORE CONSTRUCTION

E01




PROPOSED

REV	DATE	DESCRIPTION	BY
01	02.13.24	Revised as Noted	MMS
02	---		
03	---		
04	---		

REV	DATE	DESCRIPTION	BY
05	---		
06	---		
07	---		
08	---		



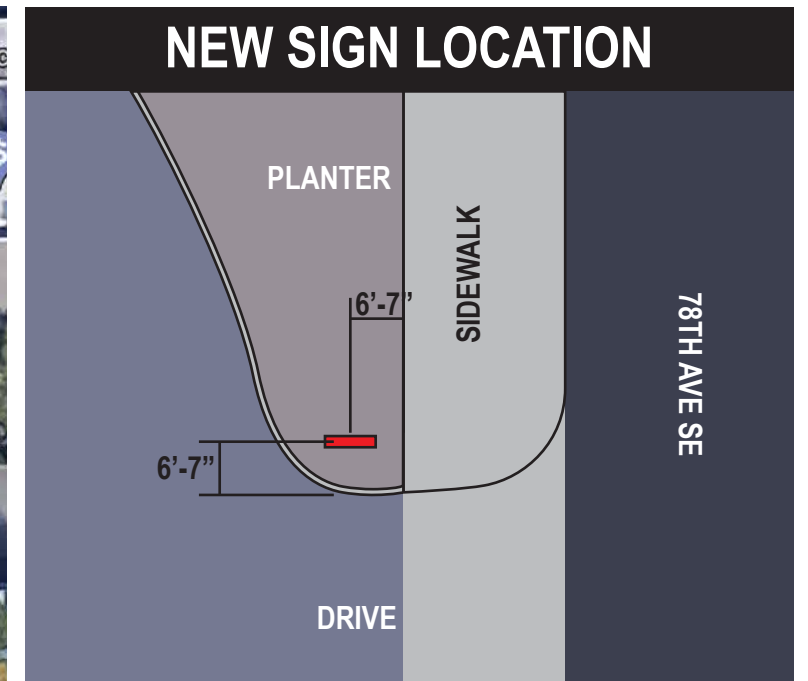

Site Triangle (Scale 1"=50'-0")



Site Plan (Scale 1"=20'-0")

NOTE: NO CHANGE TO EXISTING LANDSCAPING

 City Lights Sign Company 902 NW 49th St Seattle WA 98107 Ph: 206 -789-4747 Cell: 206-255-7029	Client:		Date:	This drawing was created to assist you. The drawing and ideas are the property of City Lights Sign Co. and cannot be replicated or used without the written permission of City Lights Sign Co. Ask your City Lights Sign Co rep for written permission.	
	WELLS FARGO		03.26.24		
	Address:	City:	Job Number:		
	3001 78TH AVE SE	MERCER ISLAND 98040			

 City Lights Sign Company 902 NW 49th St Seattle WA 98107 Ph: 206-789-4747 Cell: 206-255-7029	Client:	Date:	This drawing was created to assist you. The drawing and ideas are the property of City Lights Sign Co. and cannot be replicated or used without the written permission of City Lights Sign Co. Ask your City Lights Sign Co rep for written permission.	
	WELLS FARGO	03.26.24		
	Address:	City:		Job Number:
	3001 78TH AVE SE	MERCER ISLAND 98040		



EXISTING

NOTE: NO CHANGE TO EXISTING LANDSCAPING

CUSTOM COMMENTS:
NOTE: FIELD VERIFICATION REQUIRED BEFORE CONSTRUCTION



E02


PROPOSED

REV	DATE	DESCRIPTION	BY
01	02.13.24	Revised as Noted	MMS
02	---		
03	---		
04	---		


REV	DATE	DESCRIPTION	BY
05	---		
06	---		
07	---		
08	---		




NOTE: NO CHANGE TO EXISTING LANDSCAPING

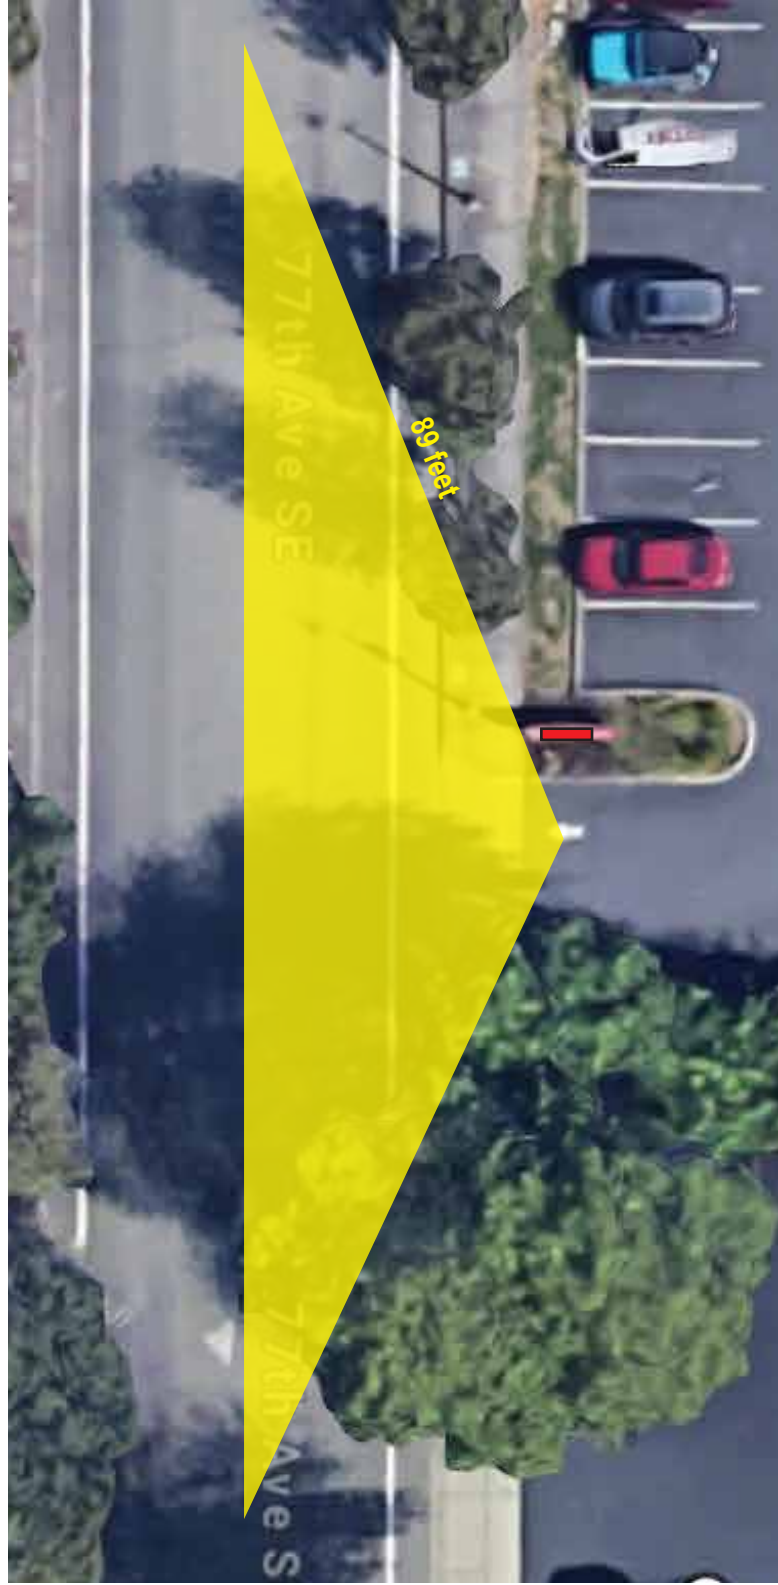

Site Triangle (Scale 1"=20'-0")

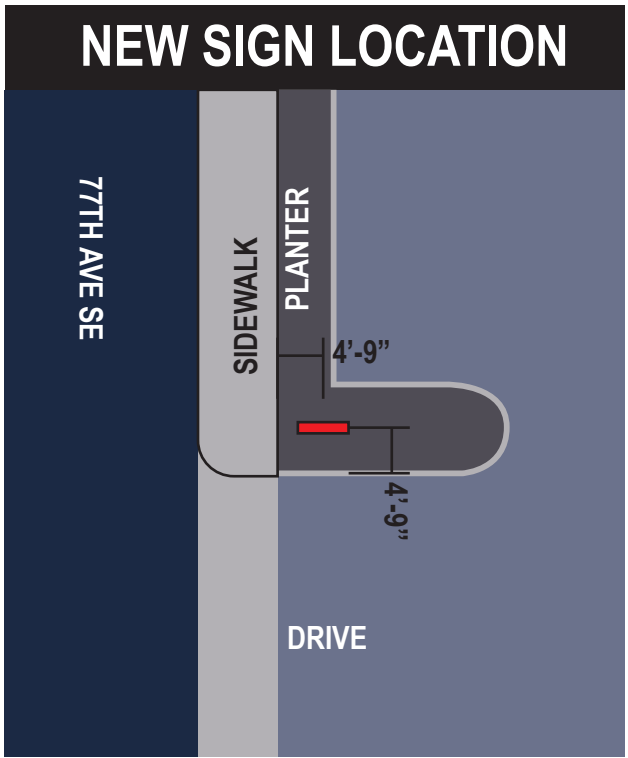


Site Plan (Scale 1"=20'-0")

 City Lights Sign Company 902 NW 49th St Seattle WA 98107 Ph: 206 -789-4747 Cell: 206-255-7029	Client:		Date:	This drawing was created to assist you. The drawing and ideas are the property of City Lights Sign Co. and cannot be replicated or used without the written permission of City Lights Sign Co. Ask your City Lights Sign Co rep for written permission.	
	WELLS FARGO		03.26.24		
	Address:	City:	Job Number:		
	3001 78TH AVE SE	MERCER ISLAND 98040			



City Lights
Sign Company
902 NW 49th St
Seattle WA 98107
Ph: 206-789-4747
Cell: 206-255-7029

Client:	WELLS FARGO	Date:	03.26.24	This drawing was created to assist you. The drawing and ideas are the property of City Lights Sign Co. and cannot be replicated or used without the written permission of City Lights Sign Co. Ask your City Lights Sign Co rep for written permission.
Address:	3001 78TH AVE SE	City:	MERCER ISLAND 98040	
Job Number:				

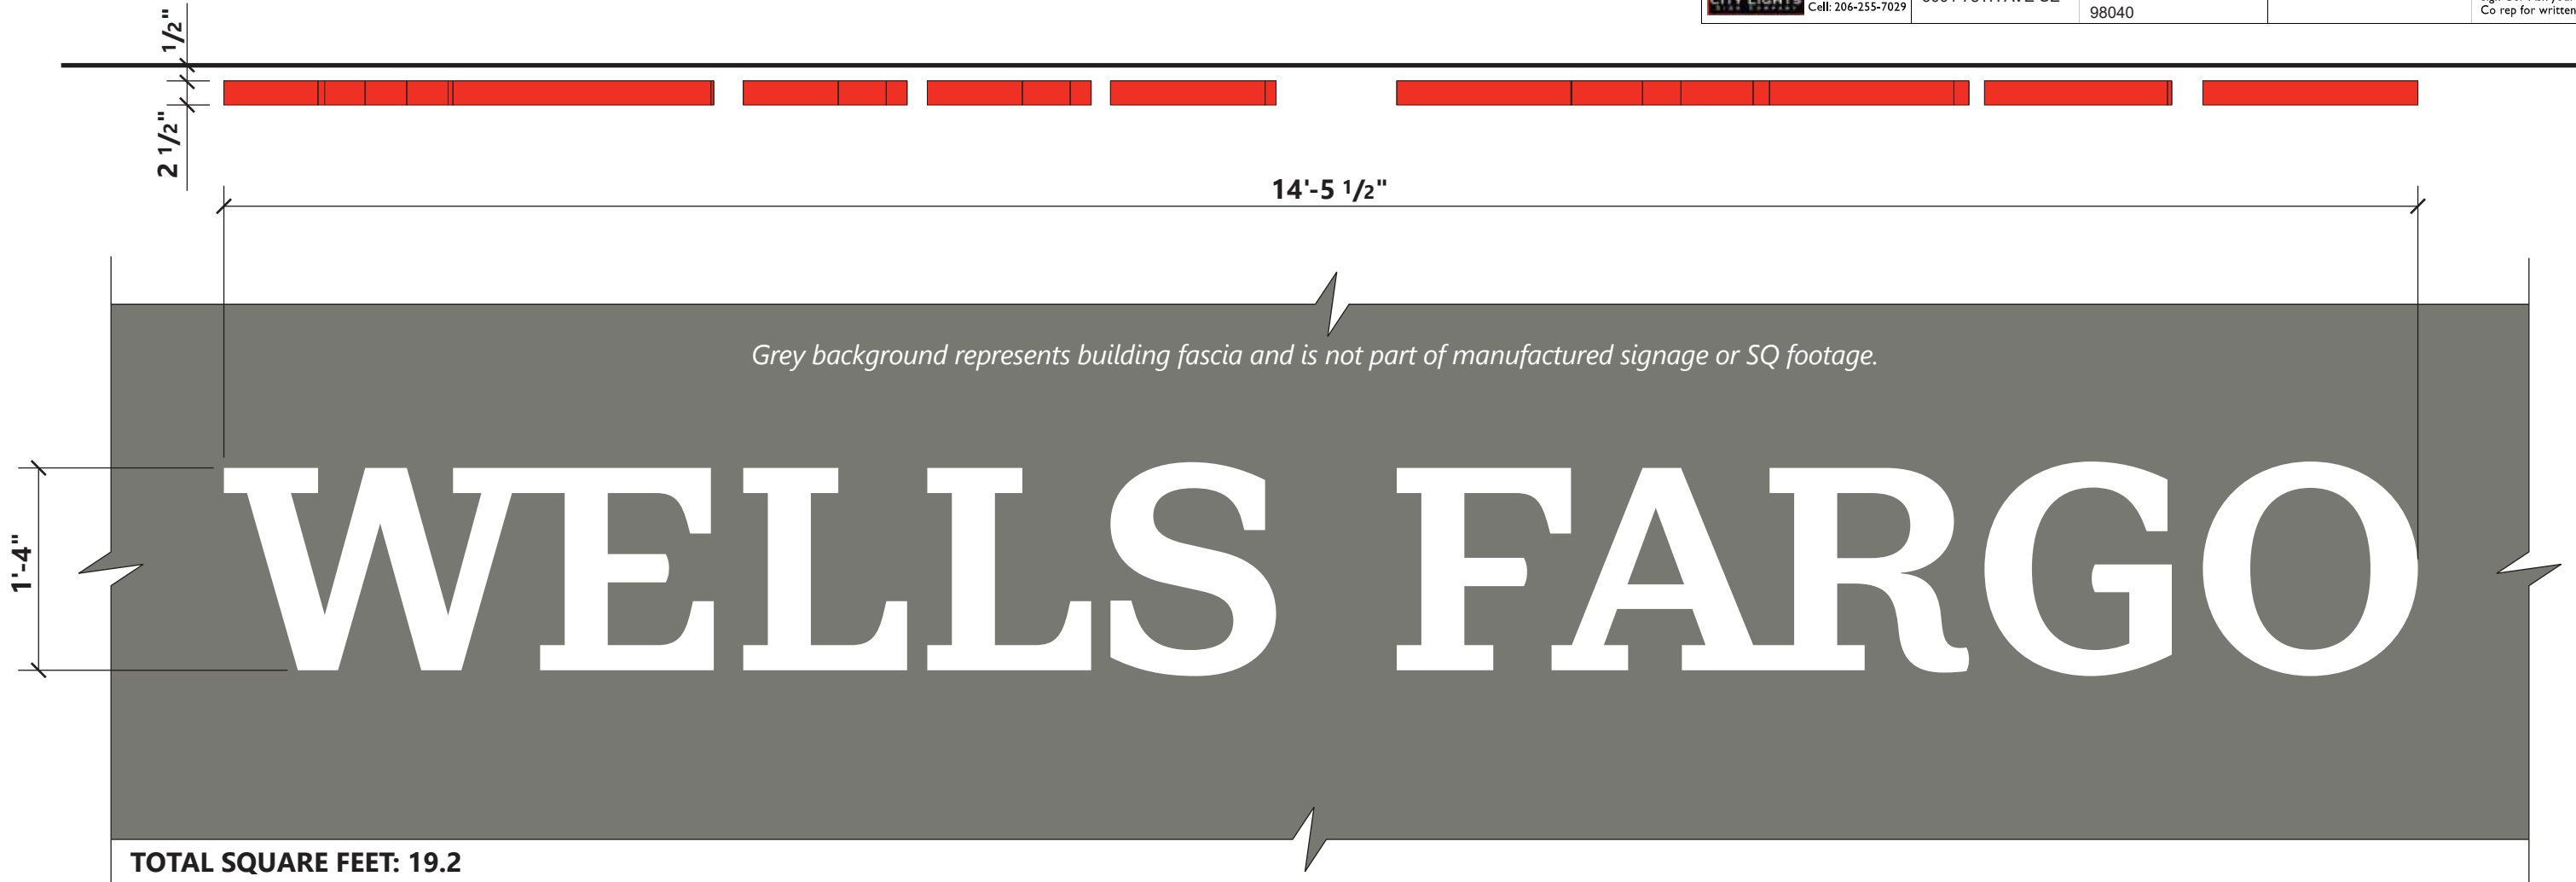


Colors and materials


- M3** Aluminum Coil, Wieland, Exxon Red
- M8** Sheet Aluminum
- M14** Acrylic, Plaskolite Optix, 2406LD, White
- P1** Paint, Wells Fargo Environments Red, Satin Finish
Option 1: Matthews Paint – MP99020, R189332 SV Satin V1.0
Brush and Roll Additive to be used for Field Application: #47-444SP
Contact Matthews Paint regarding application instructions and warranty info prior to use
Option 2: AkzoNobel – SIGN21031 GGEFx-Lv Brush and Roll Additive to be used for Field Application: #390909
Option 3: Sherwin Williams – 100679736v3 GENESIS Lustral Field application: use same product, add reducer only as needed
- V5** Translucent Vinyl, 3M 3630-20, White

Notes and requirements


- 1** **TRIMLESS LETTER FACE:** Acrylic faces with rebated edge inset into formed aluminum letters. Letter bodies are to be undersized to fit over shoulder on back of routed letter face. NOTE: Finished letter faces to be cut to exact outer contour of provided artwork at specified letter height. Rebated material to form shoulder 0.111" inside letter face contour as shown on drawing. Faces are mechanically attached to aluminum returns. Placement of trimless letters shown here limited to a maximum of 150 feet from the ground.
- 1a** 1/2" thick 2406LD standard white acrylic with first surface translucent white vinyl.
- 2** **CHANNEL LETTER RETURNS:** Formed using pre-finished aluminum coil product in approved red coating color, or from aluminum (alloy 3105) painted Wells Fargo Environments Red applied over white base coat. Seams should not be visible from ground. Thickness of returns is based on cap height of letters as follows:
16" and smaller: .050"
18" and taller: .063"
- 3** **TRIMLESS LETTER BACK:** 3/4" clear acrylic backs with rebated edge inset into formed aluminum letters. NOTE: Finished letter backs to be cut to the exact outer contour of provided artwork at specified letter height. Rebated material to form shoulder 0.08" inside letter face contour as shown on the drawing. Backs are mechanically attached to aluminum returns.
- 6** **PAINTING:** There are three paint supplier options as follows for all colors: AkzoNobel, Matthews Paint and Sherwin Williams. Paint specifications for each are noted above under Color and Materials.
- 6a** All paint colors must be applied over color compatible basecoat, as noted under Color and Materials.

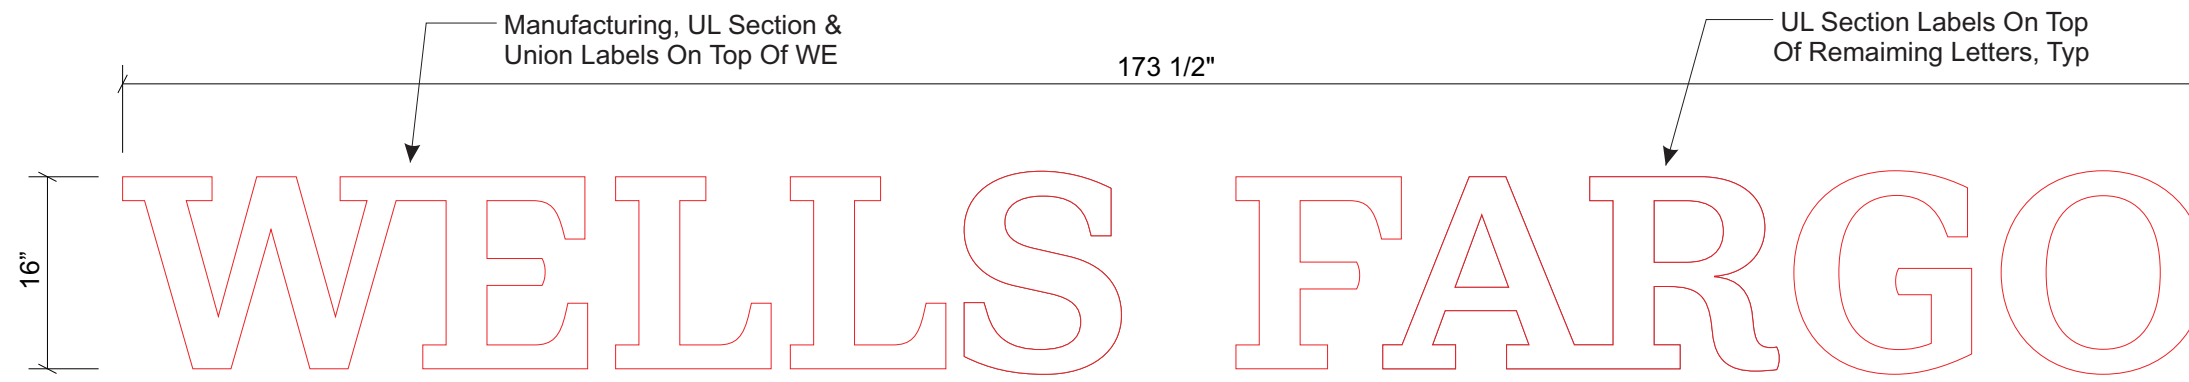

FRONT ELEVATION
WFR2-WCH-RR-FHI-H-16
(PSCo WF R2 FH WR H 16)
 SCALE: 3/4" = 1'-0"

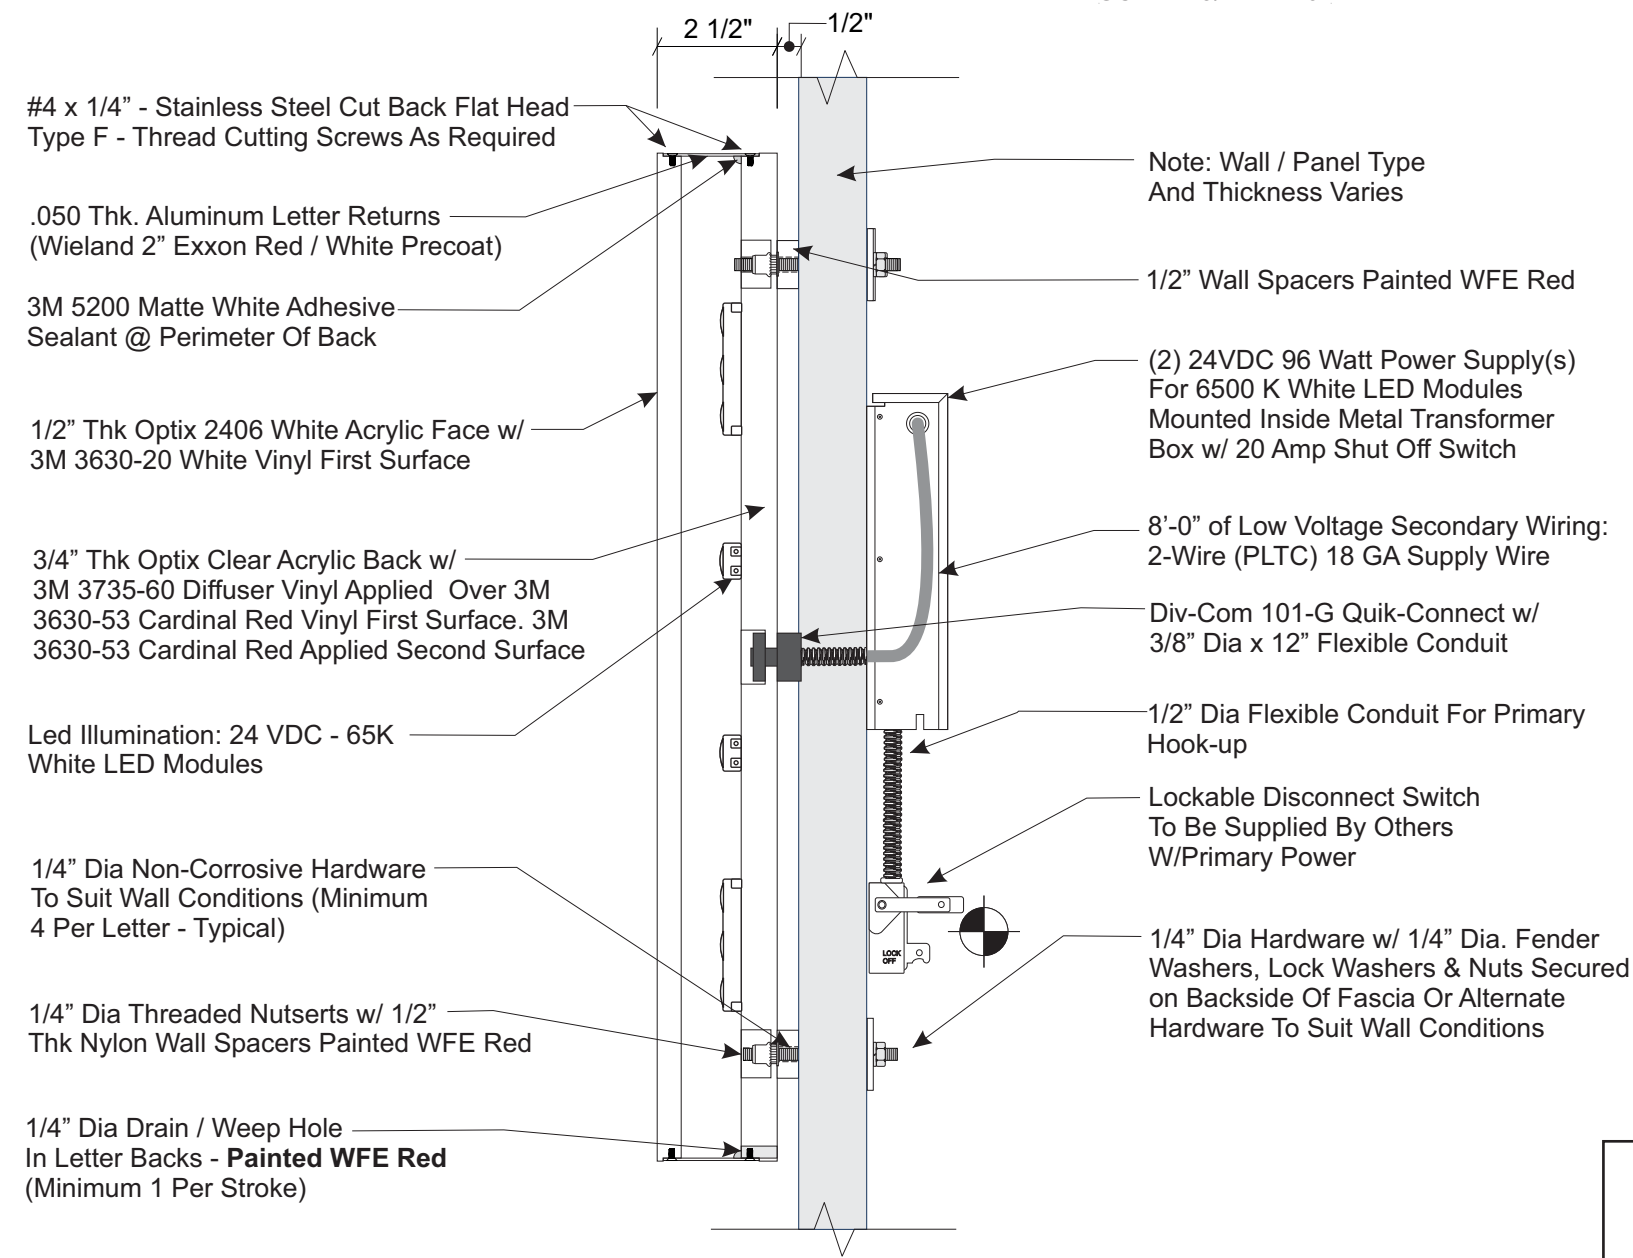

SECTION VIEW
 SCALE: 3" = 1'-0"

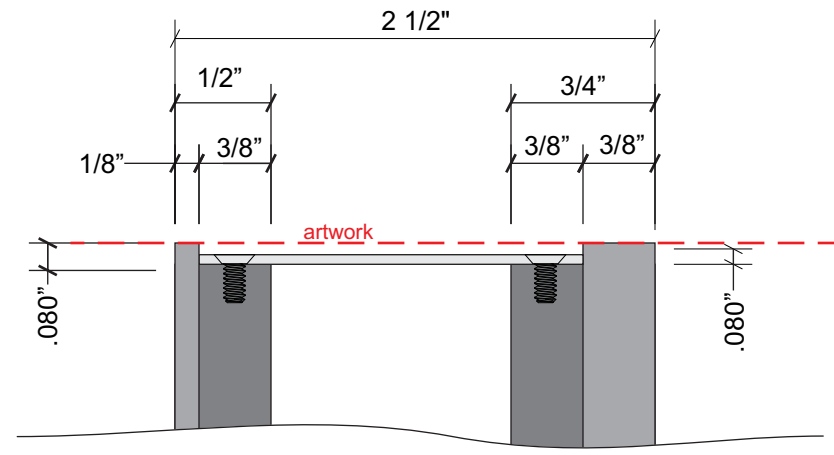


FACE / BACK DETAIL
 SCALE: FULL SIZE

PERMITS ONLY

Note: This sign is intended to be installed in accordance with the requirements of Article 600 of the NFPA 2020 National Electrical Code and/or other Applicable local codes. This Includes proper grounding and bonding of the sign.



Electrical Load
 (2.20) Amps @ 120 Volts
Electrical Req'ts
 (1) 20 Amp/120 Volt Circuits

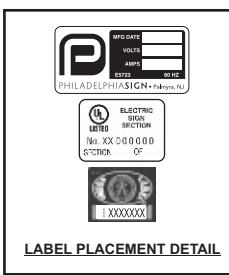

- STANDARD LETTER NOTES:**
1. Sufficient Primary Circuit In Vicinity Of Sign By Others.
 2. Letter To Letter Wiring & Final Primary Hook-up By Sign Installer, Where Allowed By Local Codes.
 3. Sign Shall Be U.L. Listed.
 4. Mounting Hardware By Sign Installer.
 5. Full Size Drilling Template Furnished With Sign.



PHILADELPHIASIGN
 BRINGING THE WORLD'S BRANDS TO LIFE

707 West Spring Garden Street
 Palmyra, New Jersey 08065

Phone: 856.829.1460
 Fax: 856.829.8549
 www.philadelphiasign.com

CUSTOMER:
WELLS FARGO - WFR2

JOB NUMBER:

SIGN TYPE:
WFR2-WCH-RR-FHI-H-16
(PSCo WF_R2_FH_WR_H_16)

LOCATION:


DATE:
04/02/2024

DRAWN BY:
BMO

REVISION:
 Number: Date: By:

SHEET: ENG DEPT
1 of 1

DWG NUMBER:
B108720

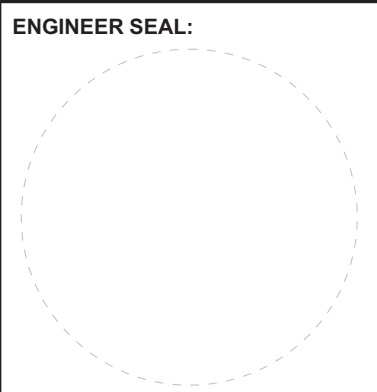

ULTIMATE WIND SPEED 115 MPH EXPOSURE C

THIS IS AN ORIGINAL UNPUBLISHED DRAWING CREATED BY PSCO. IT IS SUBMITTED FOR YOUR PERSONAL USE IN CONJUNCTION WITH A PROJECT BEING PLANNED FOR YOU BY PSCO. IT IS NOT TO BE SHOWN TO ANYONE OUTSIDE YOUR ORGANIZATION NOR IS IT TO BE USED, COPIED, REPRODUCED, OR EXHIBITED IN ANY FASHION.



EXISTING

Fascia Color - SW 6082 - Cobble Brown

WELLS FARGO


CUSTOM COMMENTS:
 NOTE: PATCH AND PAINT MAY BE REQUIRED BASED ON CONDITION OF FASCIA ONCE THE EXISTING SIGN IS REMOVED.



MOUNTED CENTERED IN EXISTING SIGN LOCATION

PROPOSED
 SCALE: 1/8" = 1'-0"

NEW SIGN LOCATION

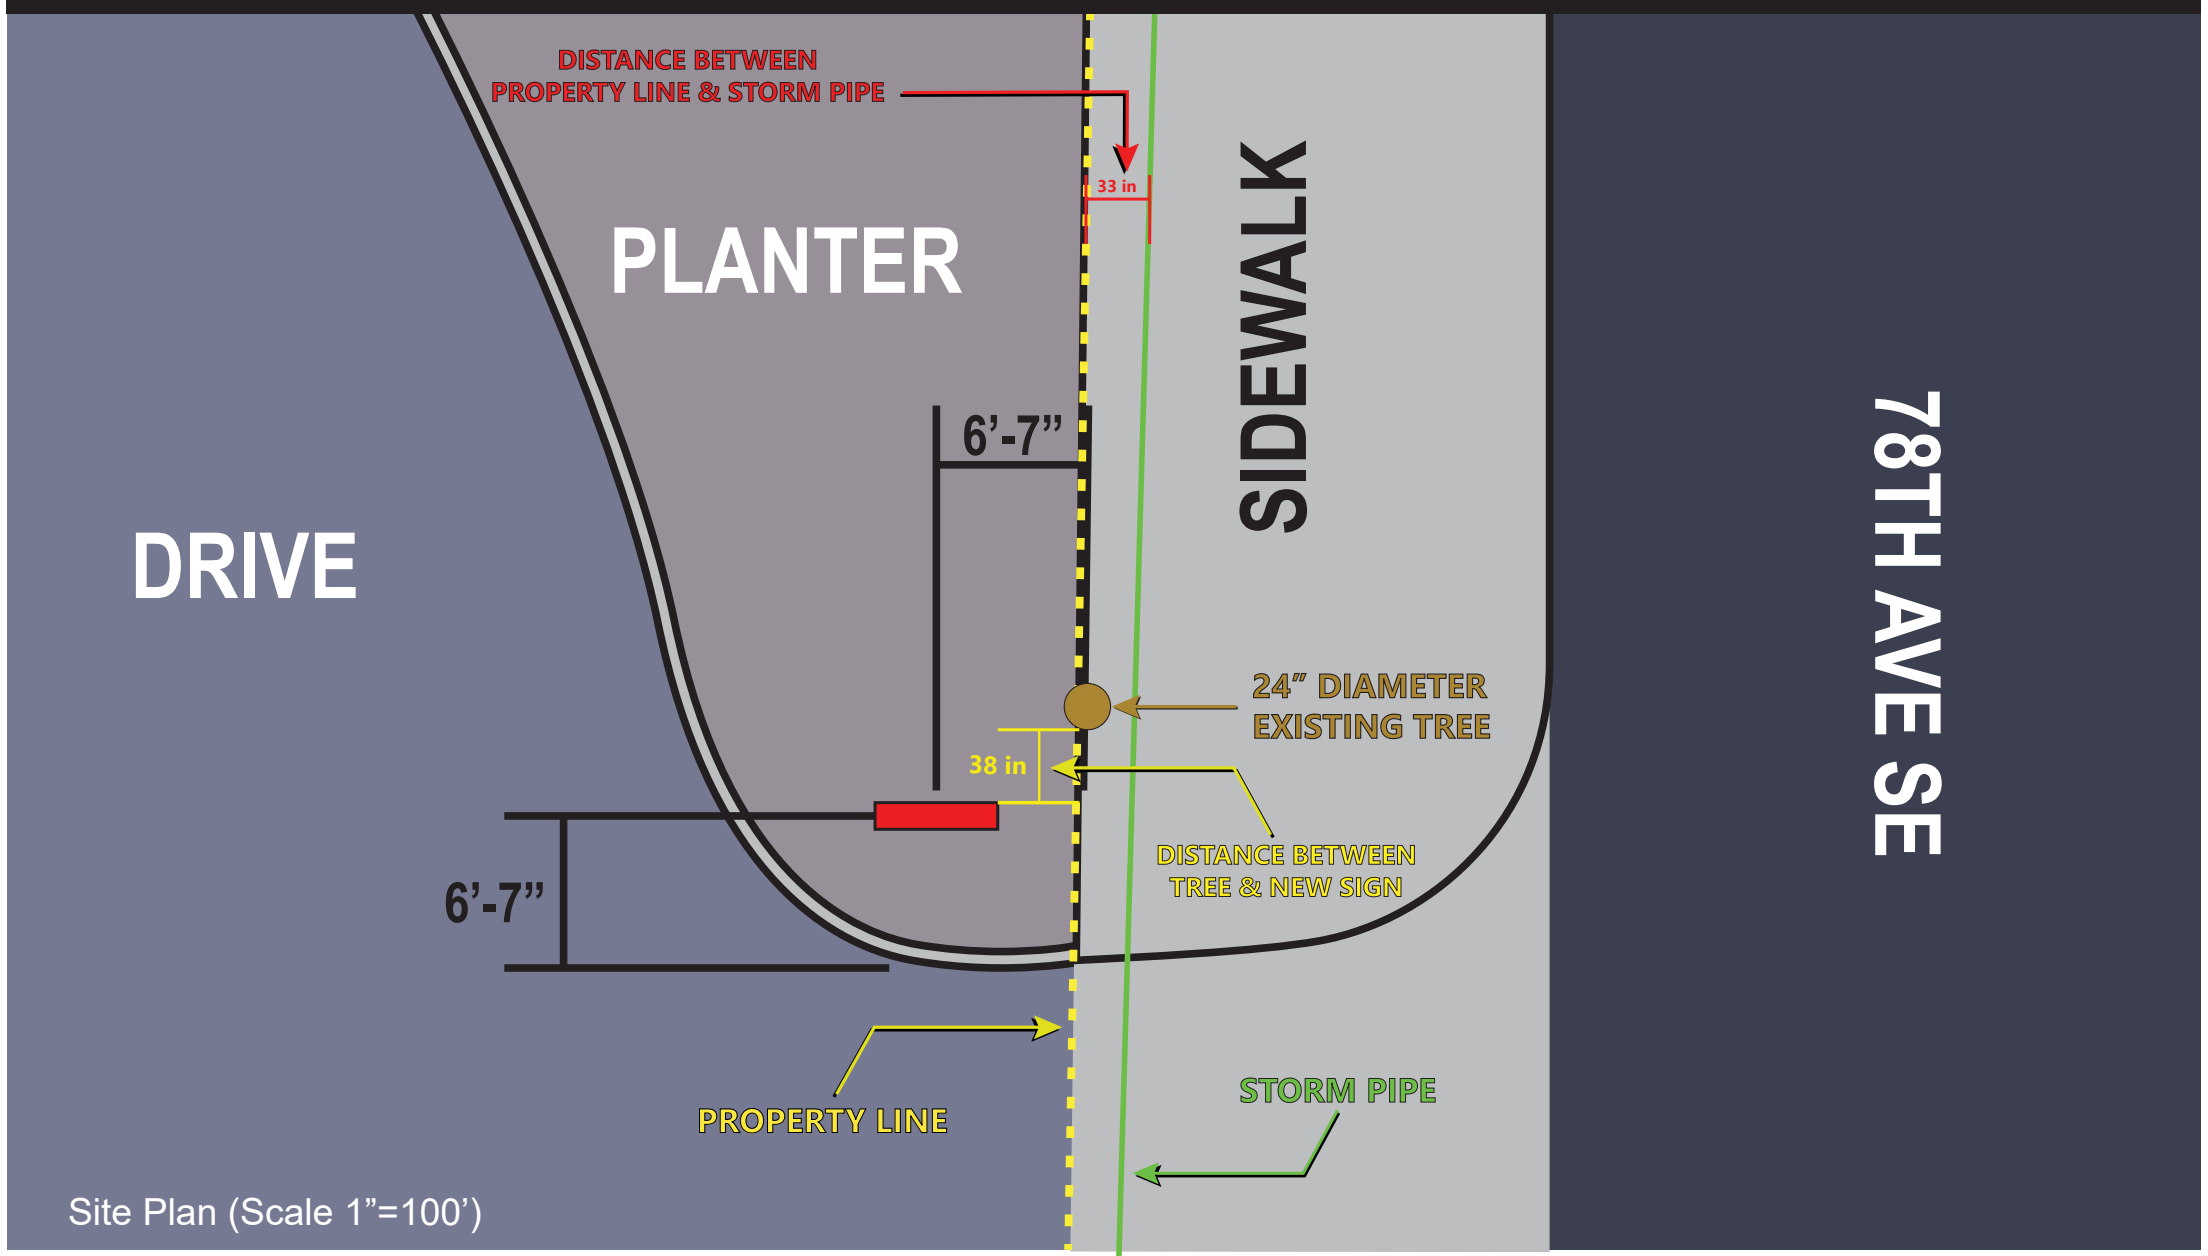

Client: WELLS FARGO		Date: 03.26.24	
Address: 3001 78TH AVE SE	City: MERCER ISLAND 98040	Job Number:	

This drawing was created to assist you. The drawing and ideas are the property of City Lights Sign Co. and cannot be replicated or used without the written permission of City Lights Sign Co. Ask your City Lights Sign Co rep for written permission.