

SEPA Environmental Checklist
Mercer Island Center for the Arts

Attachment S
Storm Drainage Plan

March 2017




PROJECT NUMBER	A1611.00
PERMIT NUMBER	
DATE	20161018
PROJECT TEAM	LCS
CHECK	MJJ
REVISION	

SCALE	1" = 20'
SHEET NAME	STORM DRAINAGE PLAN

SHEET NUMBER	C501
--------------	-------------

***NOTE**
THERE ARE PIPES LEAVING CB 7057 HEADING EAST, CB 7150 EAST OF HERE HAS NO PIPES TO THE WEST. IT IS POSSIBLE THAT THESE PIPES TEE INTO THE 36" PIPE THAT HEADS TO THE NORTH.

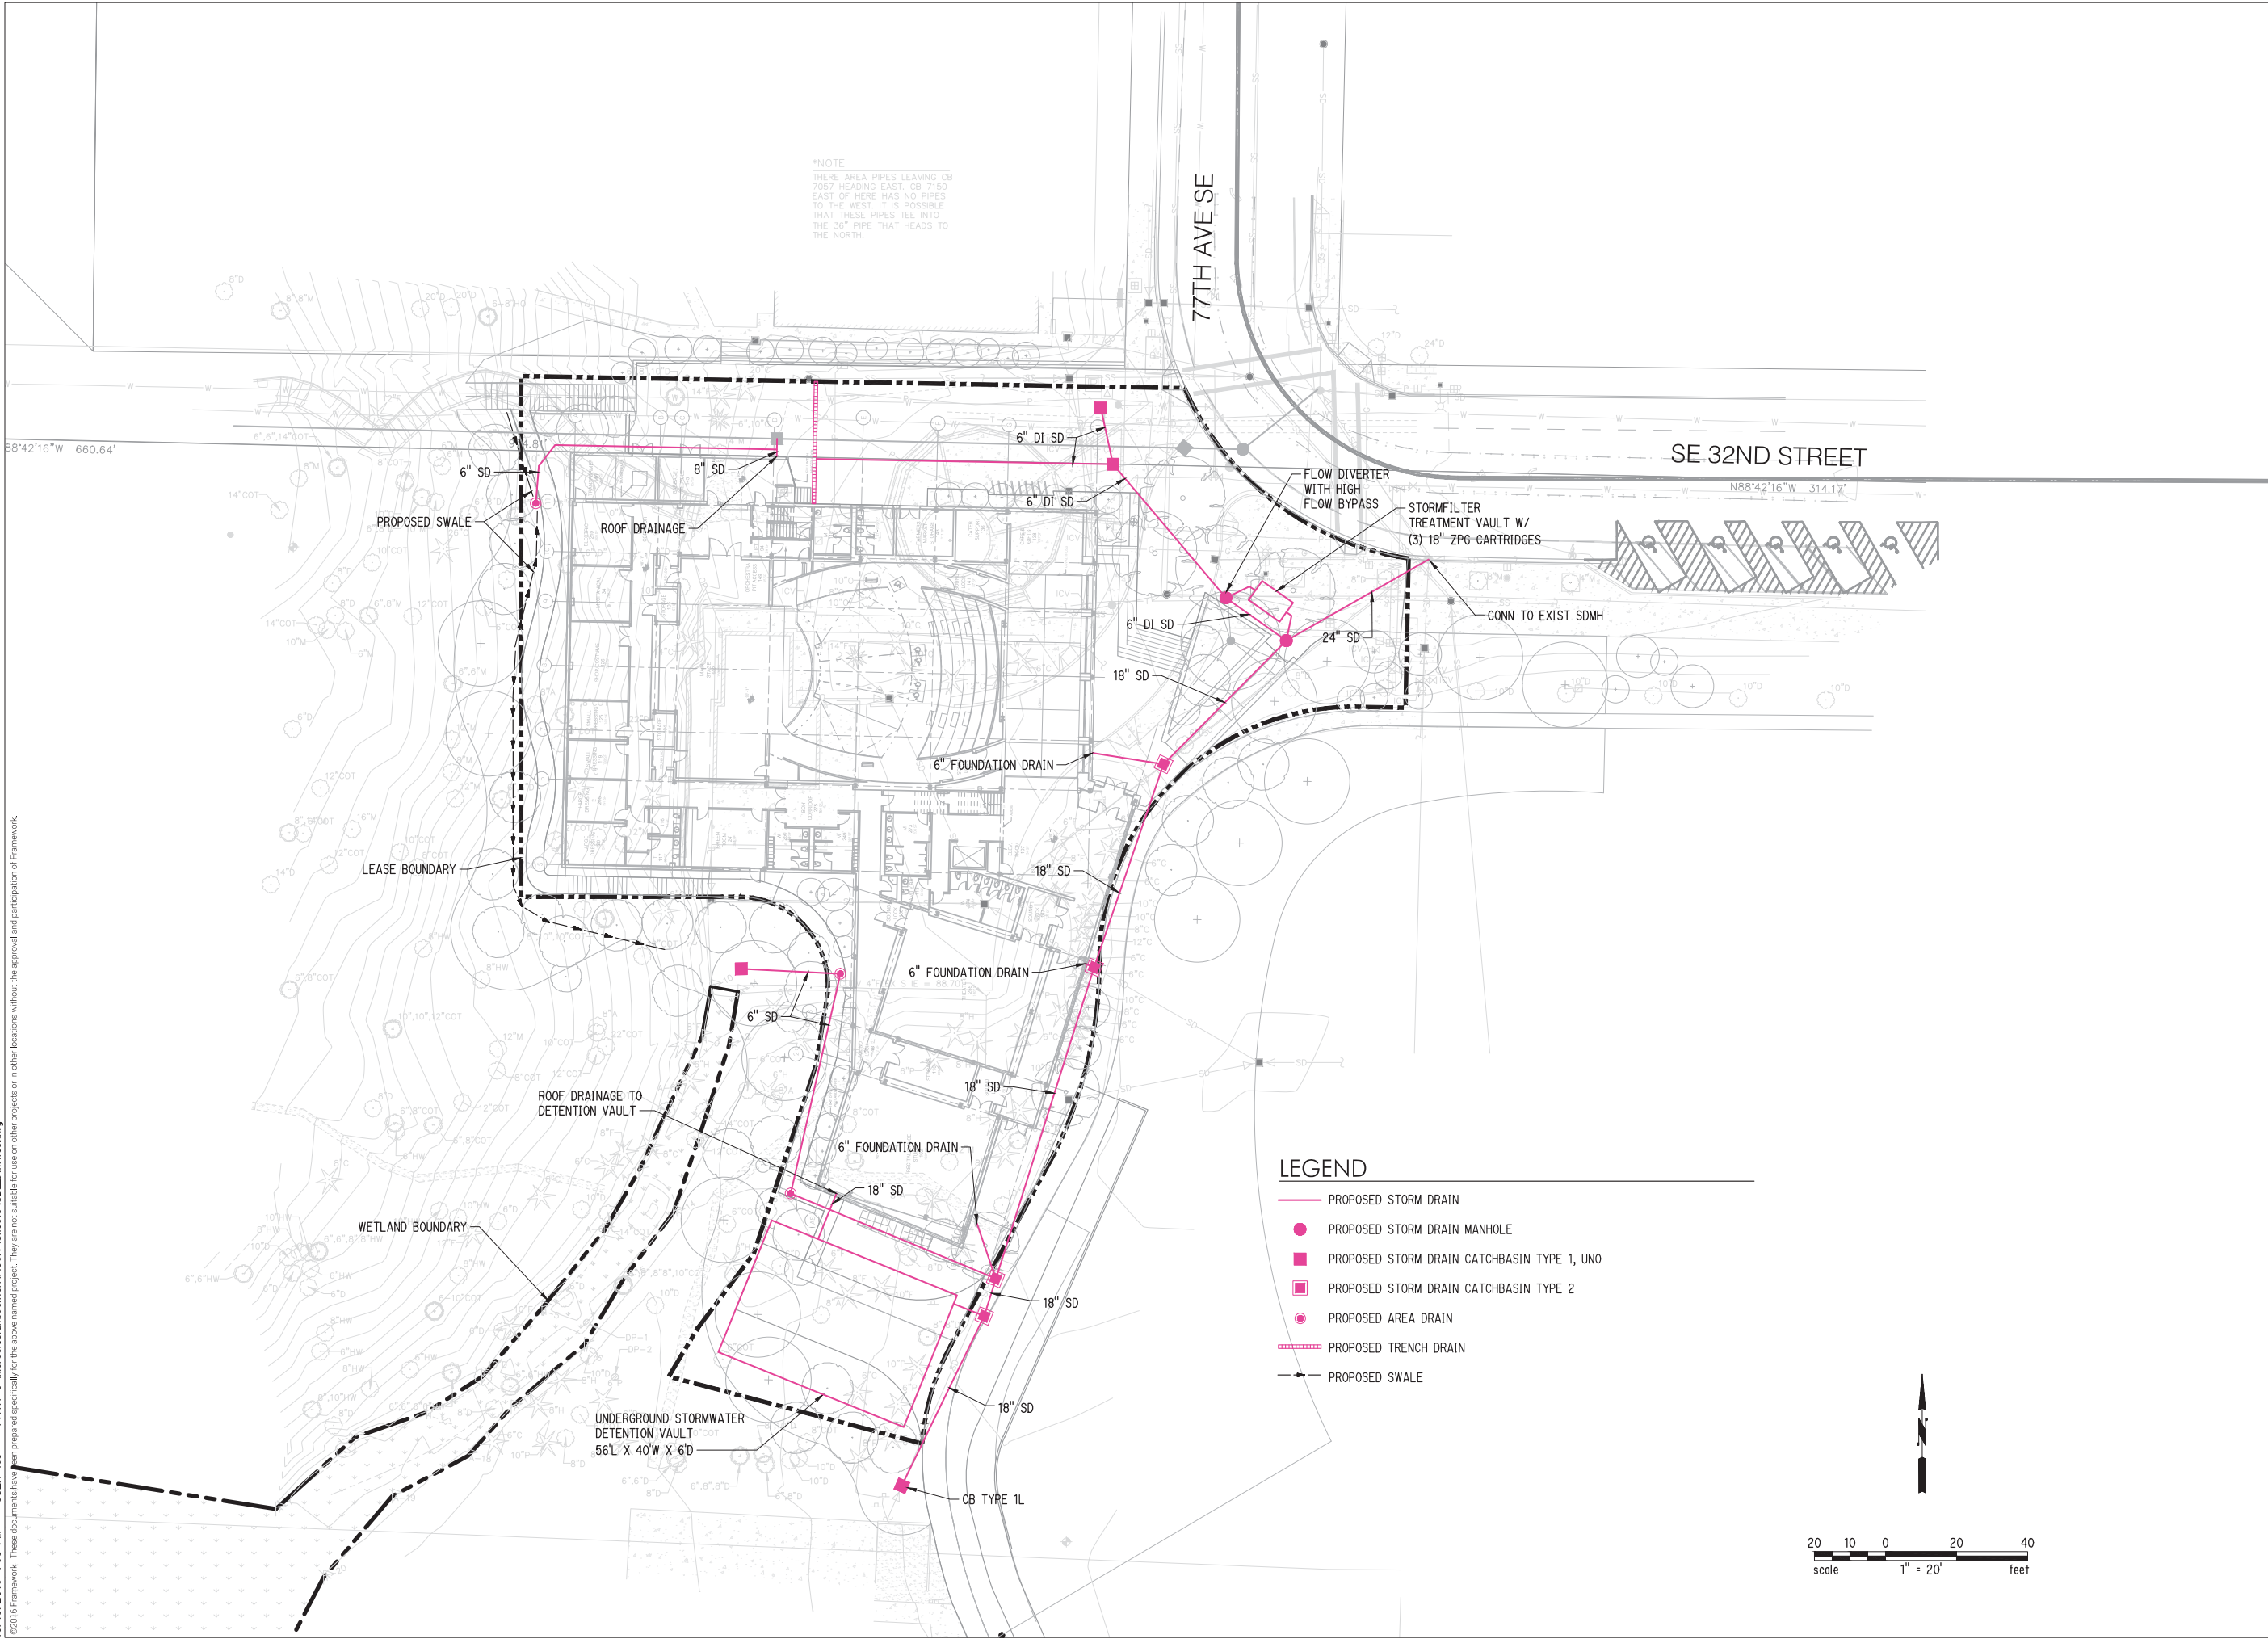

- LEGEND**
- PROPOSED STORM DRAIN
 - PROPOSED STORM DRAIN MANHOLE
 - PROPOSED STORM DRAIN CATCHBASIN TYPE 1, UNO
 - PROPOSED STORM DRAIN CATCHBASIN TYPE 2
 - PROPOSED AREA DRAIN
 - PROPOSED TRENCH DRAIN
 - - - PROPOSED SWALE